



TO ORDER PLANS GO TO [Idiline.com](http://idiline.com)

**MAIN LEVEL FLOOR PLAN FIRE PROTECTION PIPING LAYOUT**  
SCALE 1/8" = 1'-0"

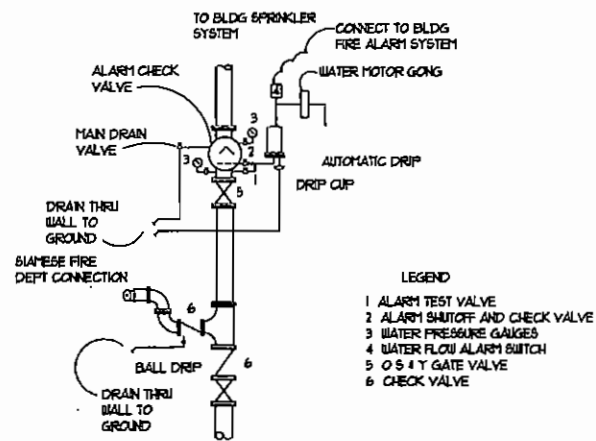


**SPRINKLER RISER DETAIL**  
SCHEMATIC ONLY

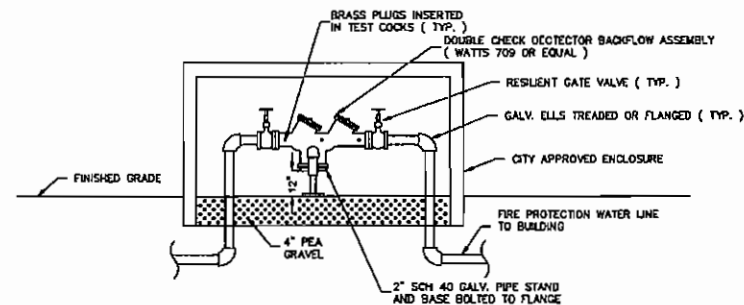

**6" DOUBLE CHECK DETECTOR VALVE BACKFLOW PREVENTOR**  
N.T.S.

RELEASED FOR CONSTRUCTION  
DATE 3/12/07 BY: *cmw*



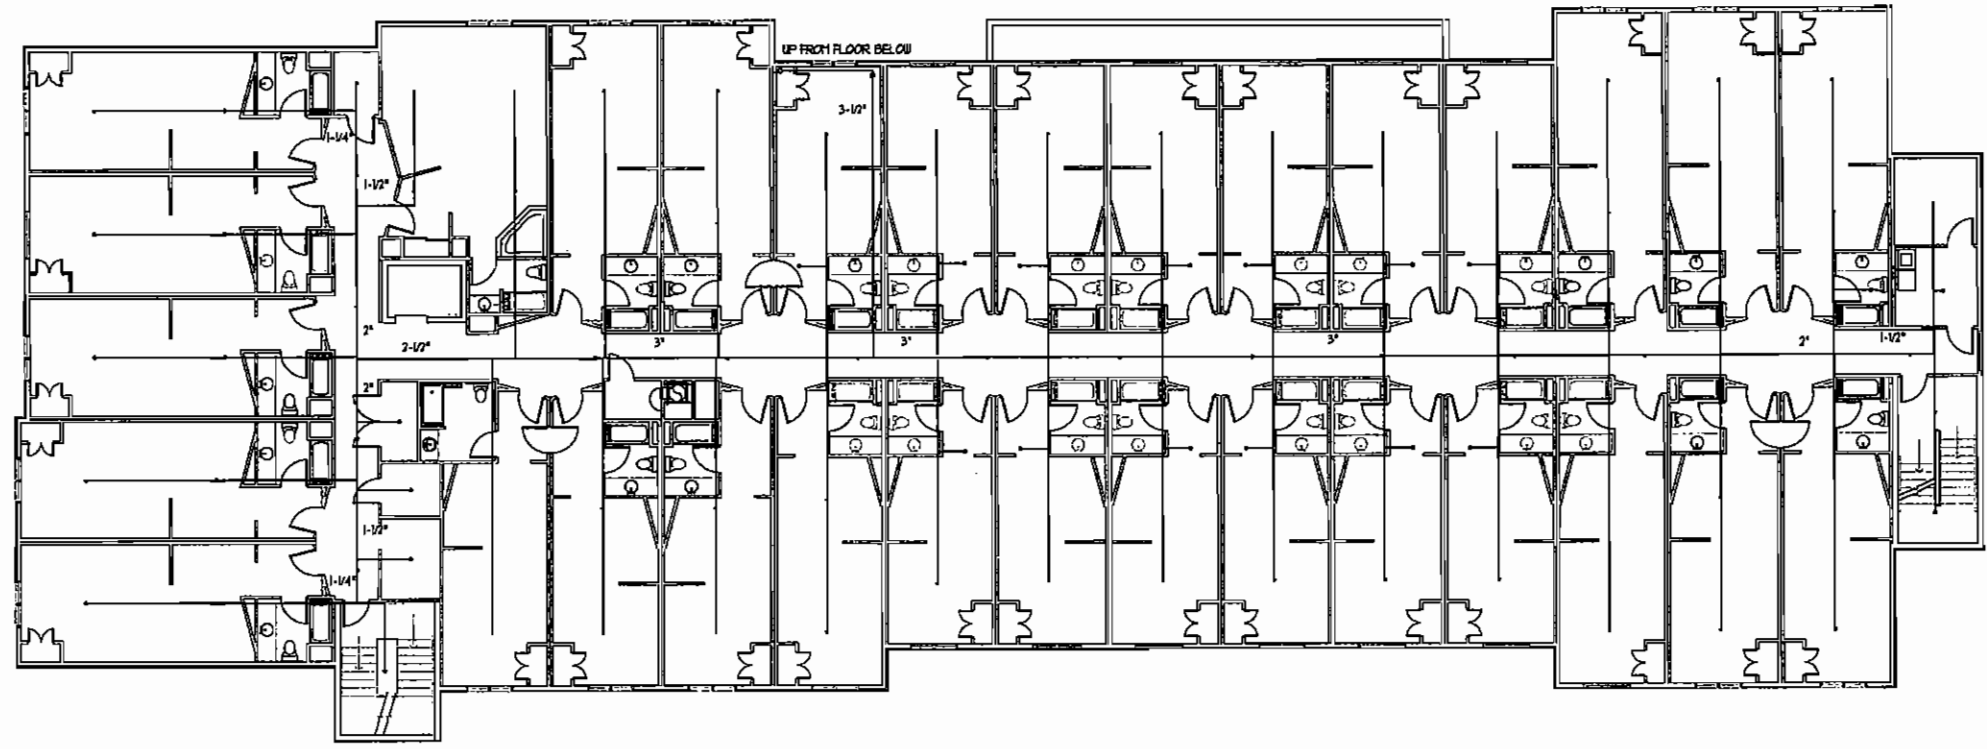

SECOND LEVEL FLOOR PLAN FIRE PROTECTION PIPING LAYOUT  
**TO ORDER PLANS GO TO [Idiline.com](http://Idiline.com)**

*PRX Services*  
 1245 Rainey Road  
 Macon, Georgia 30216

PROPOSED 75 ROOM MOTEL FOR  
**COMFORT SUITES**  
 MACON, GEORGIA  
 SHRUTI CORPORATION, OWNER




**Wolf & Associates Architects**  
 MAISON, GEORGIA - 400 STONEY BROOKS, 2ND FLOOR  
 PHONE 478-742-8811 FAX 478-742-8898  
 WHEELAND, NORTH CAROLINA - 740 DENVER COVERLAND, 3RD FL  
 PHONE 610-254-8865 FAX 610-254-8865

DATE 2/26/07

RELEASED FOR  
 CONSTRUCTION  
 DATE 3/12/07 BY: *SW*


SHEET NO.  
 FP1.2

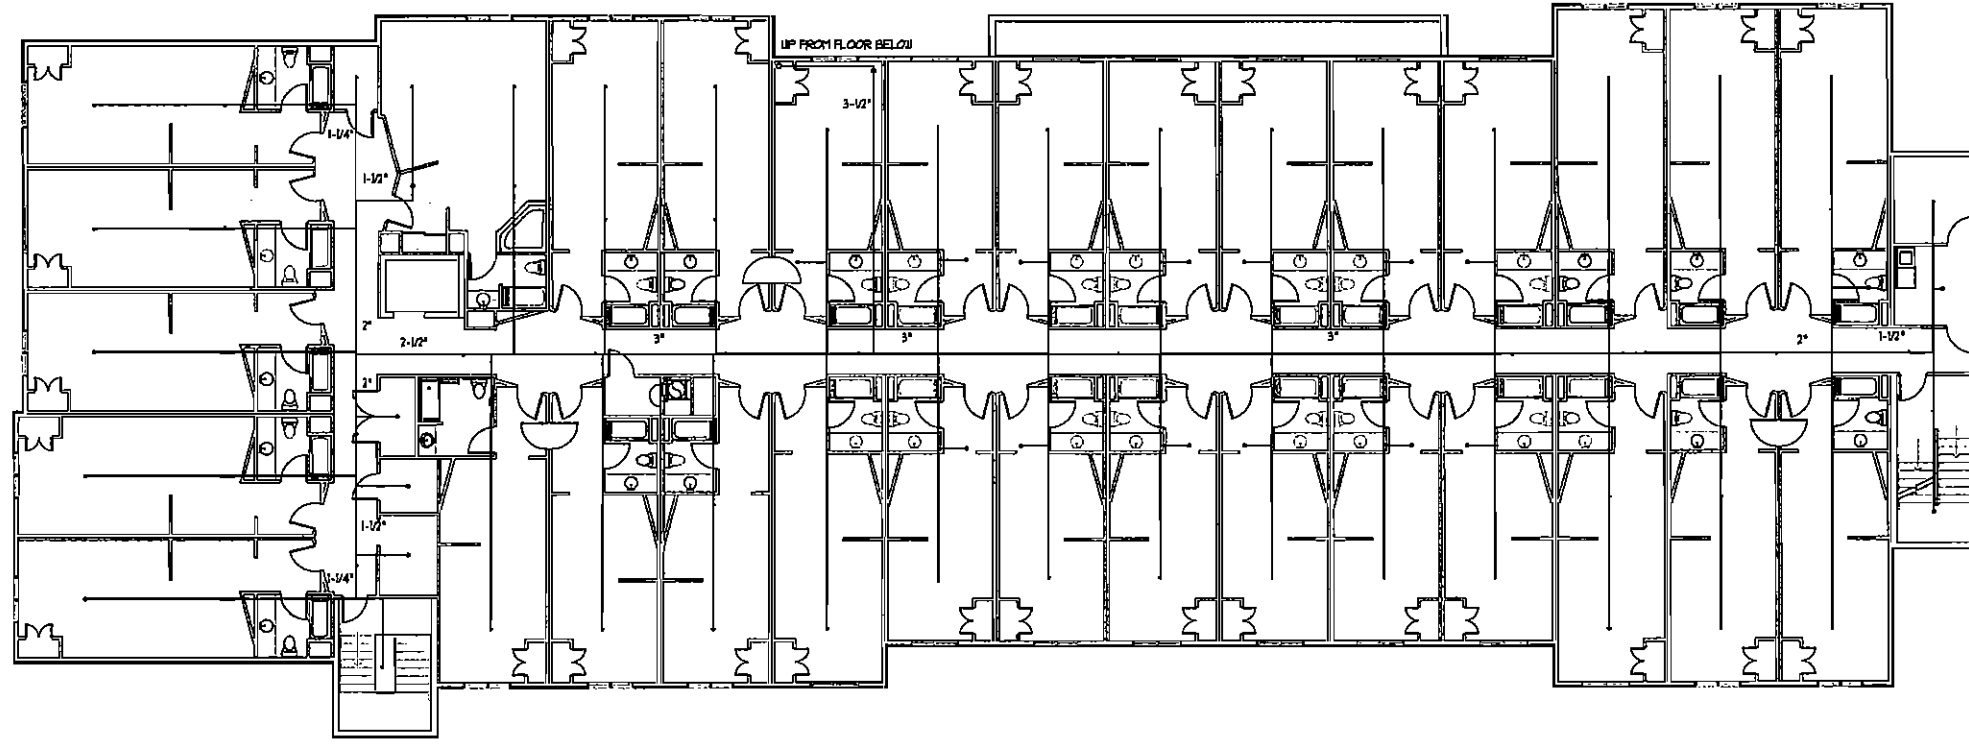

THIRD LEVEL FLOOR PLAN FIRE PROTECTION PIPING LAYOUT  
**TO ORDER PLANS GO TO [Idiline.com](http://Idiline.com)**

**PRK Services**  
 1245 Rainey Road  
 Macon, Georgia 31204

PROPOSED 75 ROOM MOTEL FOR  
**COMFORT SUITES**  
 MACON, GEORGIA  
 SHERUTI CORPORATION, OWNER

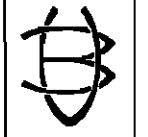

**Wolf & Associates Architects**  
 MACON, GEORGIA - 448 BROWNWOOD RD, 31210  
 PHONE 779-241-8113 FAX 779-274-4280  
 ATLANTA, GEORGIA - 740 BENTON COWY BLVD, 30341  
 PHONE 404-525-4995 FAX 404-525-4995

DATE 2/26/07

RELEASED FOR  
 CONSTRUCTION  
 DATE 3/12/07 BY: *ctw*

SHEET NO.  
 FP1.3