

Building Classifications International Building Code 2003			
Building Information			
Occupancy	Type of Construction	Allowable Stories	Stories Provided
Assembly A-3	Type II - B Unsprinklered	2 stories	1 story
Floor Areas			
Level/Floor	Allowable Floor Areas	Floor Areas Provided	
First Floor	9,500 sf	3,024 sf	

As per Table 503

Fire Resistance Requirements International Building Code 2003			
Component	Rating Required	Rating Provided	Assembly
Structural Frame - including columns, girders, trusses	0*	0*	NA
Bearing Walls - Exterior	2	3	12" Conc. NA
Bearing Walls - Interior	0	3	
Nonbearing Walls and Partitions - Exterior	0	3	
Nonbearing Walls and Partitions - Interior	0	0	NA
Roof Construction - including supporting beams and joists	0	3	NA

As per Table 601
* Where Required by Table 704.8

Building Occupant Load International Building Code 2003			
Occupancy	Square Footage	S.F. per Occupant	Occupant Load
Assembly A-3	1,942 sf	7 net	278
First Floor Total Occupants			278

As per Table 1004.1.2


Plumbing Fixture Requirements International Building Code 2003						
Occupant Load - 278	Water Closets		Lavatories		Water Fountains	
	required	provided	required	provided	required	provided
	2m/ 2f	2/ 2	1 ea sex	2 ea sex	1	1

As per Table 2003.1
*one (1) service sink to be provided for building

Means of Egress Requirements International Building Code 2003							
Occupant Load	Min. No. of Exits Required	Number of Exits Provided	Min. Exit Width Required	Min. Exit Width Provided	Min. Stair Width Required	Stair Width Provided	Max. Distance to Exit Allowed
278 First Floor	2	2	36"	72" Each Location	NA	NA	200 feet


As per Tables 1005.1, 1014.1, 1015.1, 1016.1, 1018.1
* per Table 1014.2
** Accessible Egress

FIRE PROTECTION / LIFE SAFETY LEGEND	
	3 HOUR WALL CONSTRUCTION 12' REINFORCED CONCRETE
	EGRESS PATH-DIRECTION OF TRAVEL
	FIRE EXTINGUISHER CABINET

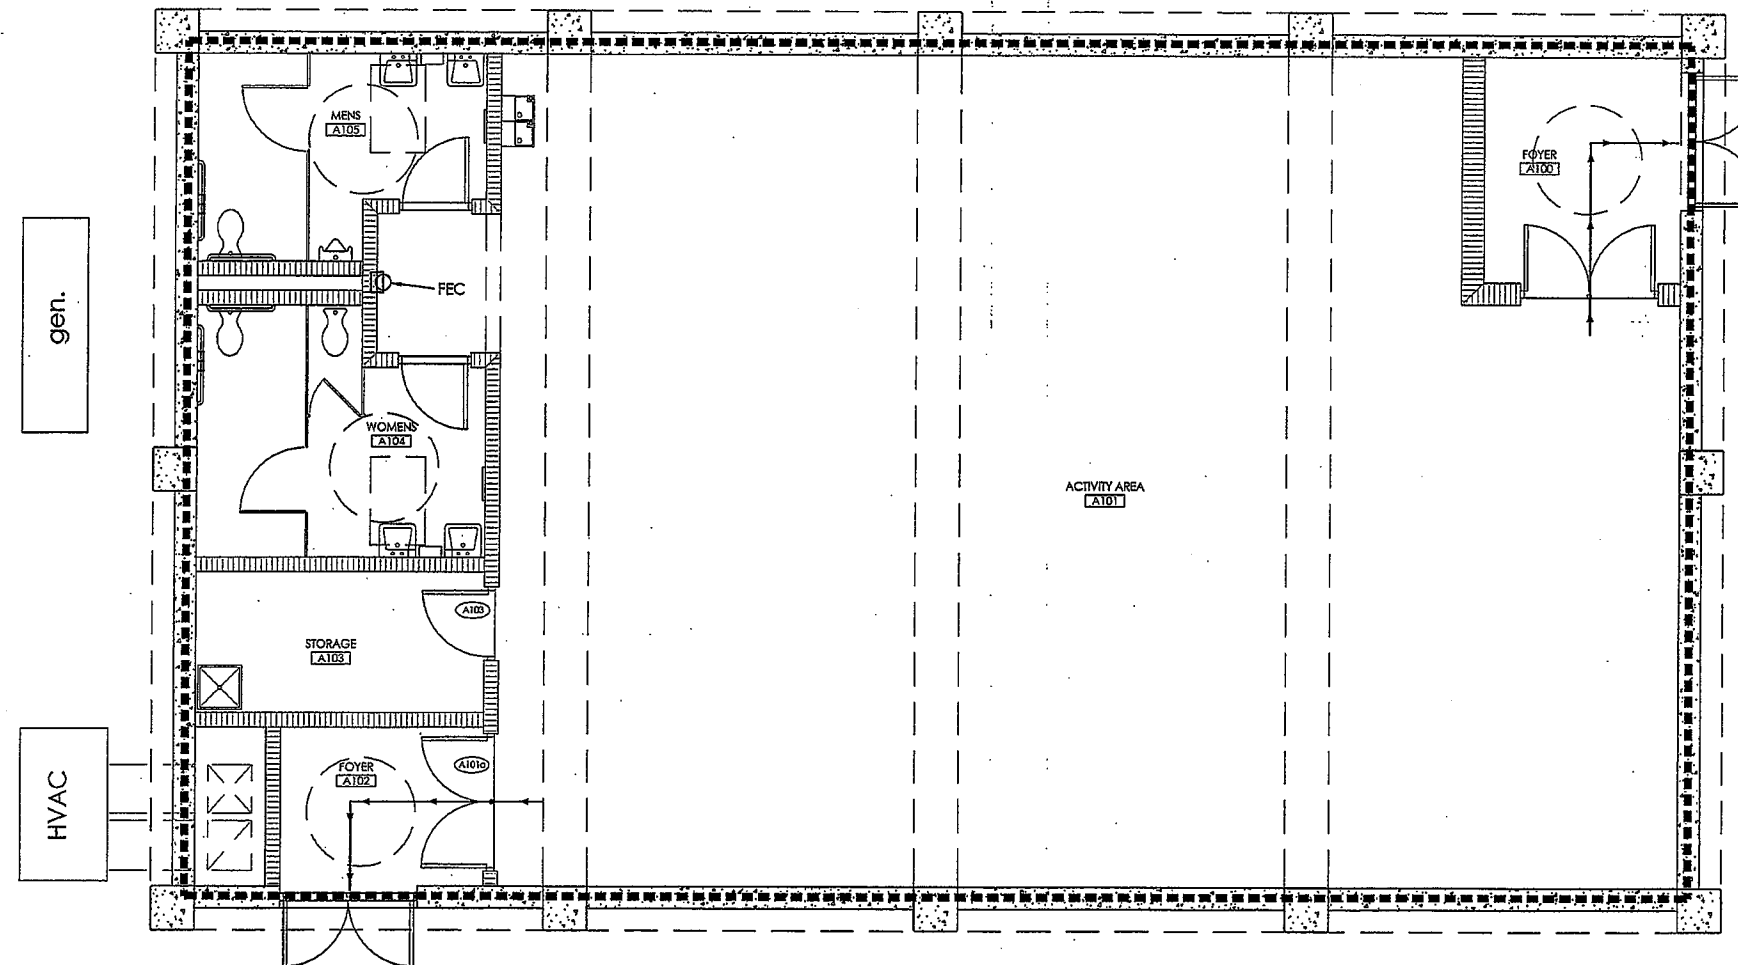

1 LIFE SAFETY PLAN
LS1.1 1/4" = 1'-0"

Community Shelter Buildings for the
Bibb County Commission
Bibb County, Alabama

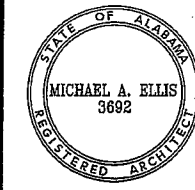

Please Note:
These documents and their reproductions are the property of the Architect. The reproduction of these documents is strictly prohibited, without the written consent of the Architect.

Copyright 2007
Ellis Architects, Inc.
Do Not Scale From Drawings.
Contractor must verify all dimensions prior to construction.

JOB No.	0514
DATE:	REV DATE:
04/06/07	05/07/07
DRAWN BY:	GLL/JP
Life Safety Plan	
SCALE: AS NOTED	
SHEET NUMBER	LS1.1

EllisArchitects
631 Helen Keller Boulevard, Suite 300
Dozier, Alabama 35004
www.ellisarchitects.com

For other plans, go to www.ellisarchitects.com