




PARTIAL FLOOR PLAN - PLUMBING
1/4" = 1'-0"

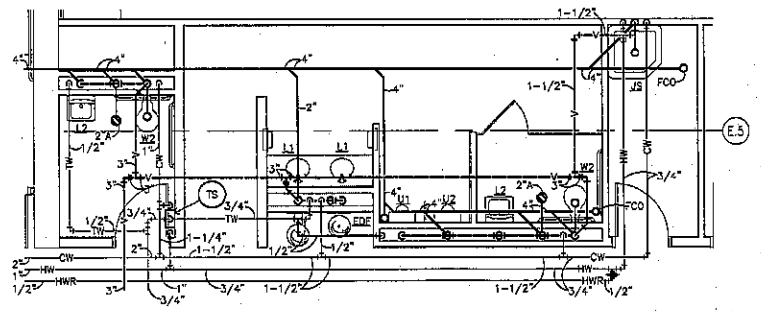


PARTIAL FLOOR PLAN - PLUMBING
1/4" = 1'-0"

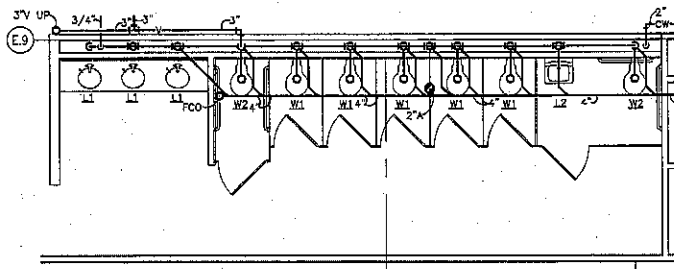


PARTIAL FLOOR PLAN - PLUMBING
1/4" = 1'-0"

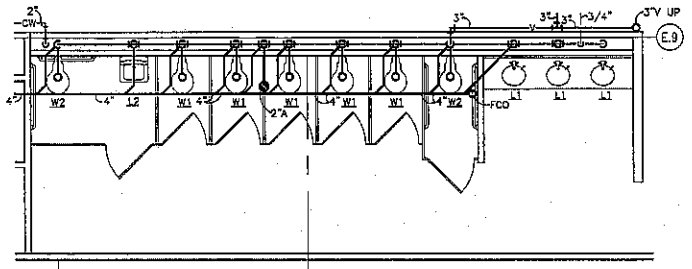


PARTIAL FLOOR PLAN - PLUMBING
1/4" = 1'-0"

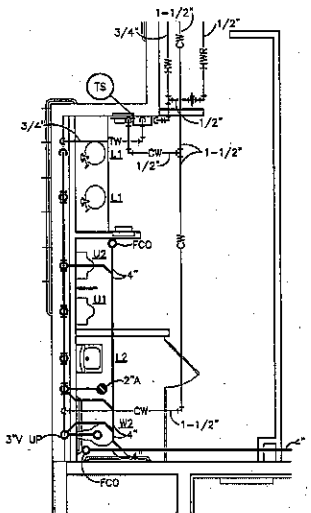


PARTIAL FLOOR PLAN - PLUMBING
1/4" = 1'-0"

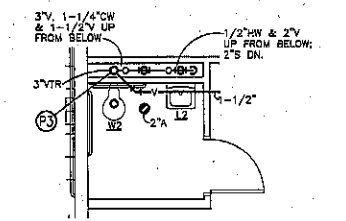


PARTIAL MEZZANINE FLOOR PLAN - PLUMBING
1/4" = 1'-0"

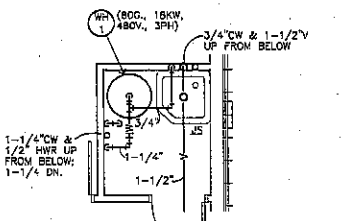

PARTIAL MEZZANINE FLOOR PLAN - PLUMBING
1/4" = 1'-0"

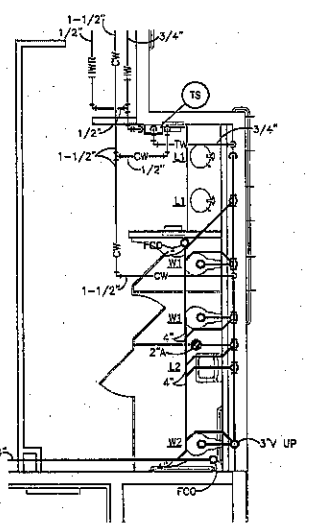

PARTIAL FLOOR PLAN - PLUMBING
1/4" = 1'-0"

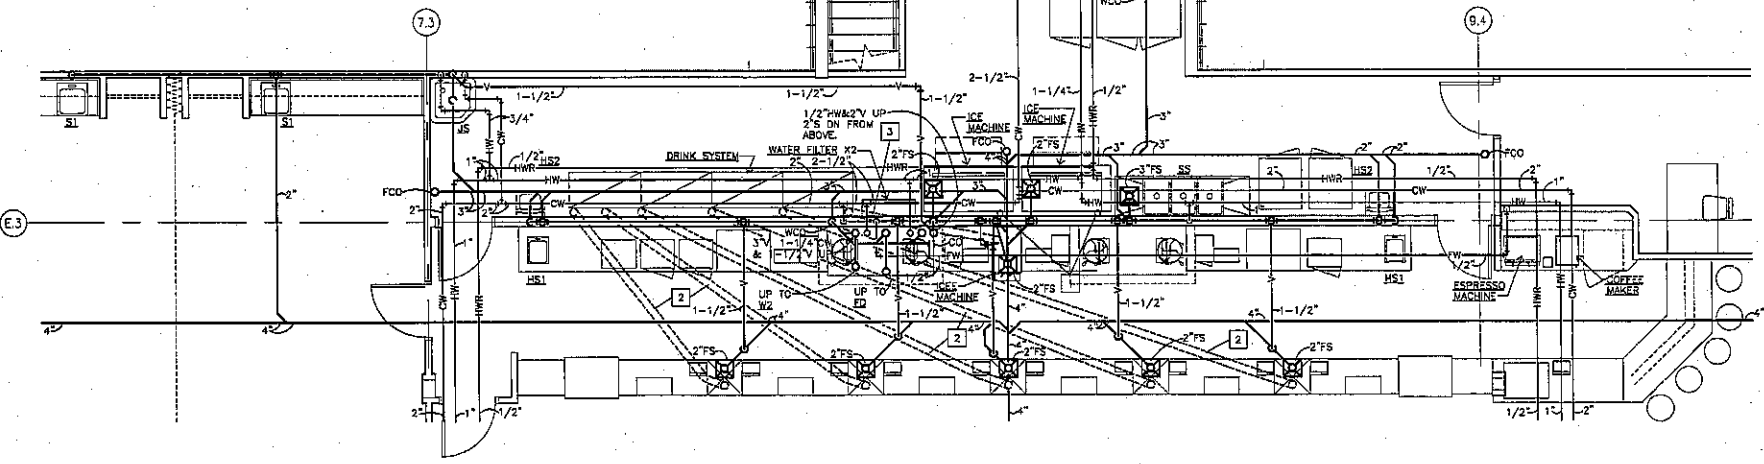

PARTIAL FLOOR PLAN - PLUMBING
1/4" = 1'-0"

- PLAN NOTES**
1. INSTALL OWNER FURNISHED REFRIGERANT PIPING SET FROM ICE MACHINE TO REMOTE CONDENSOR ON ROOF.
 2. 6" PVC W/ LONG RADIUS BENDS FOR DRINK LINES. TYPICAL FOR (S) SLEEVES FOR (S) SYSTEMS.
 3. 6" PVC W/ LONG RADIUS BENDS FOR ICE LINES. TYPICAL FOR (I) SLEEVES FOR (I) SYSTEMS.

Scale 1/8" = 1'-0"
Date 06/18/07
File # 010342-0302

100 West 11th
Fort Lauderdale, FL 33304
(954) 462-7632



ROLLING HILLS
ST. JOHN'S COUNTY, FLORIDA



BID SET
06/18/07

REVISION LOG



NO.	DATE	FOR

JOB NO.: 06045.01
DWG. BY: WDR CHK. BY: BER

PARTIAL FLOOR PLANS - PLUMBING

SHEET NO.


P3

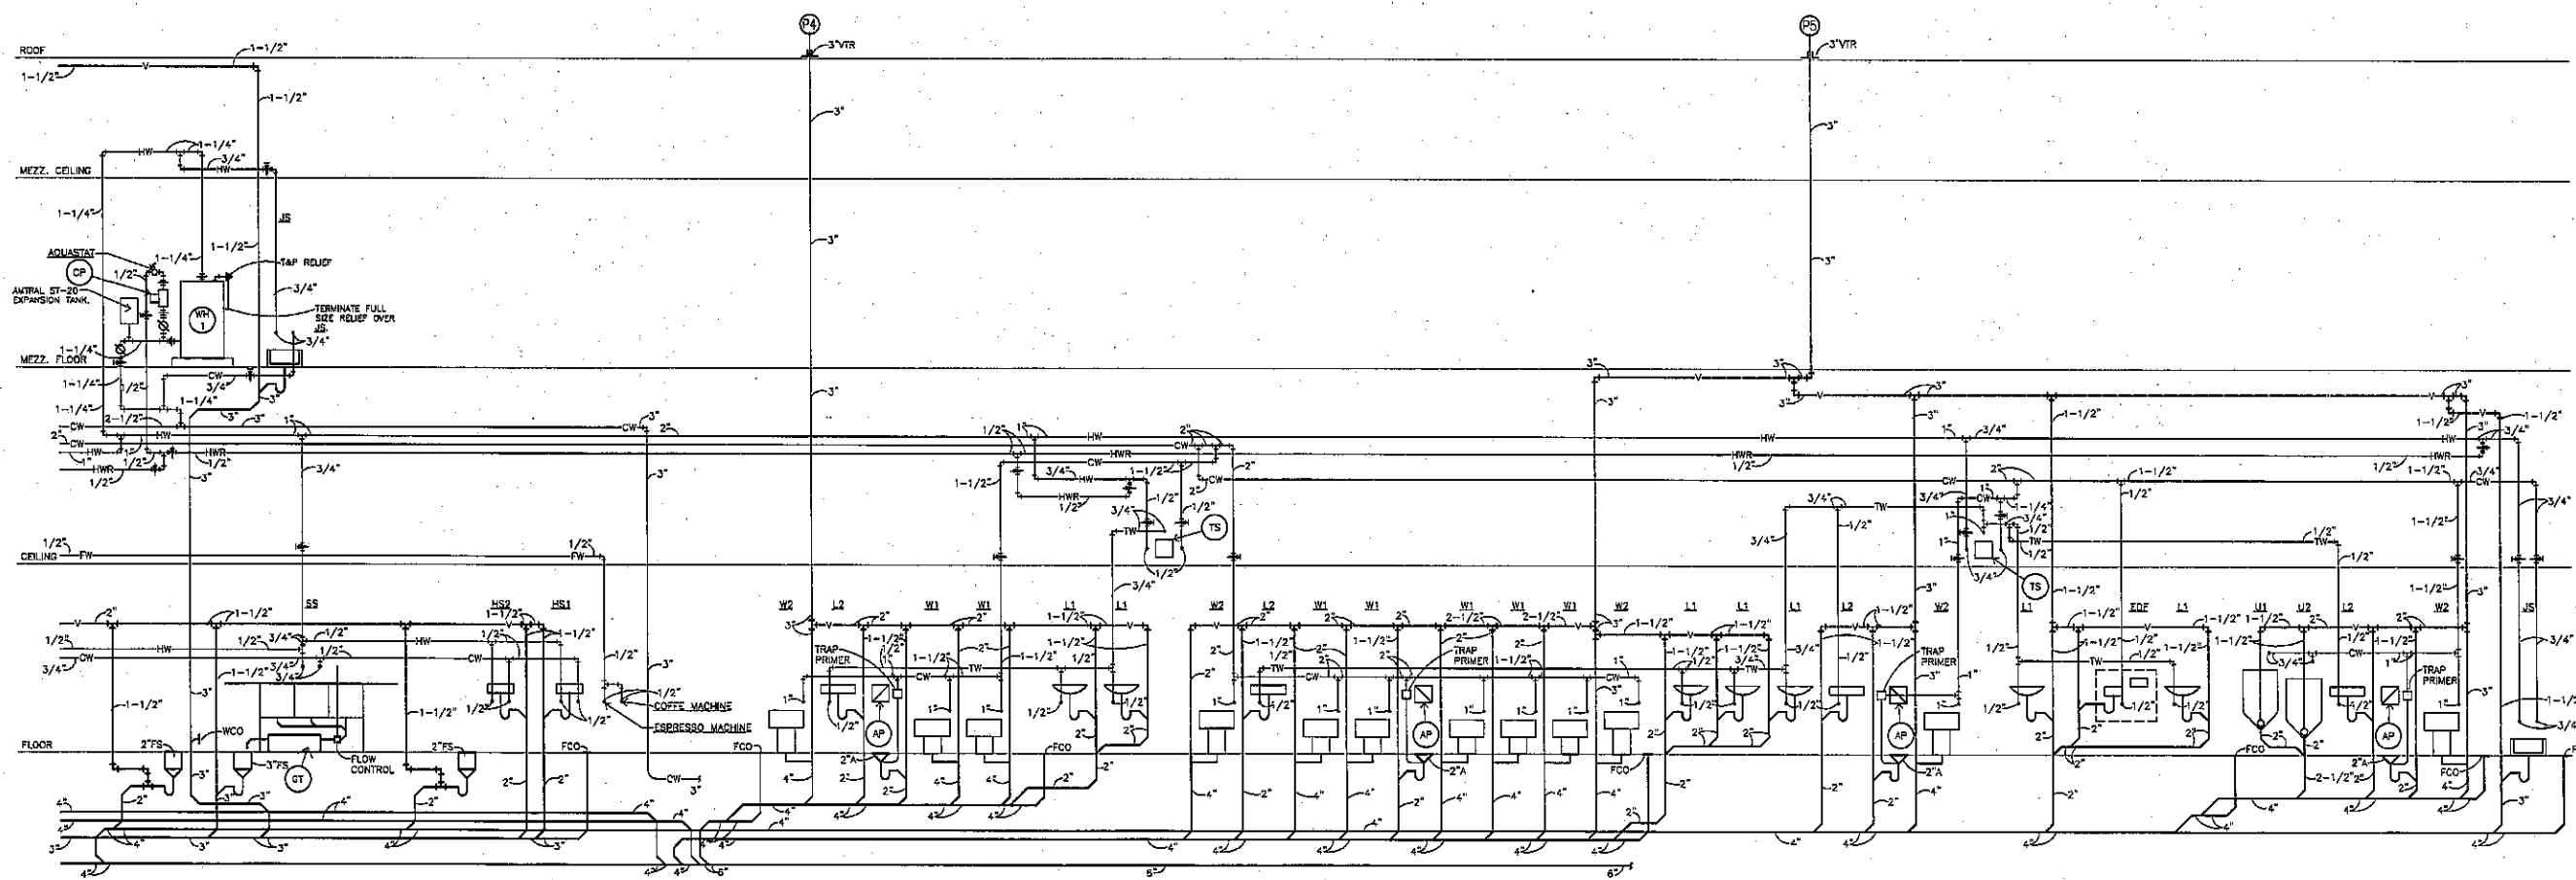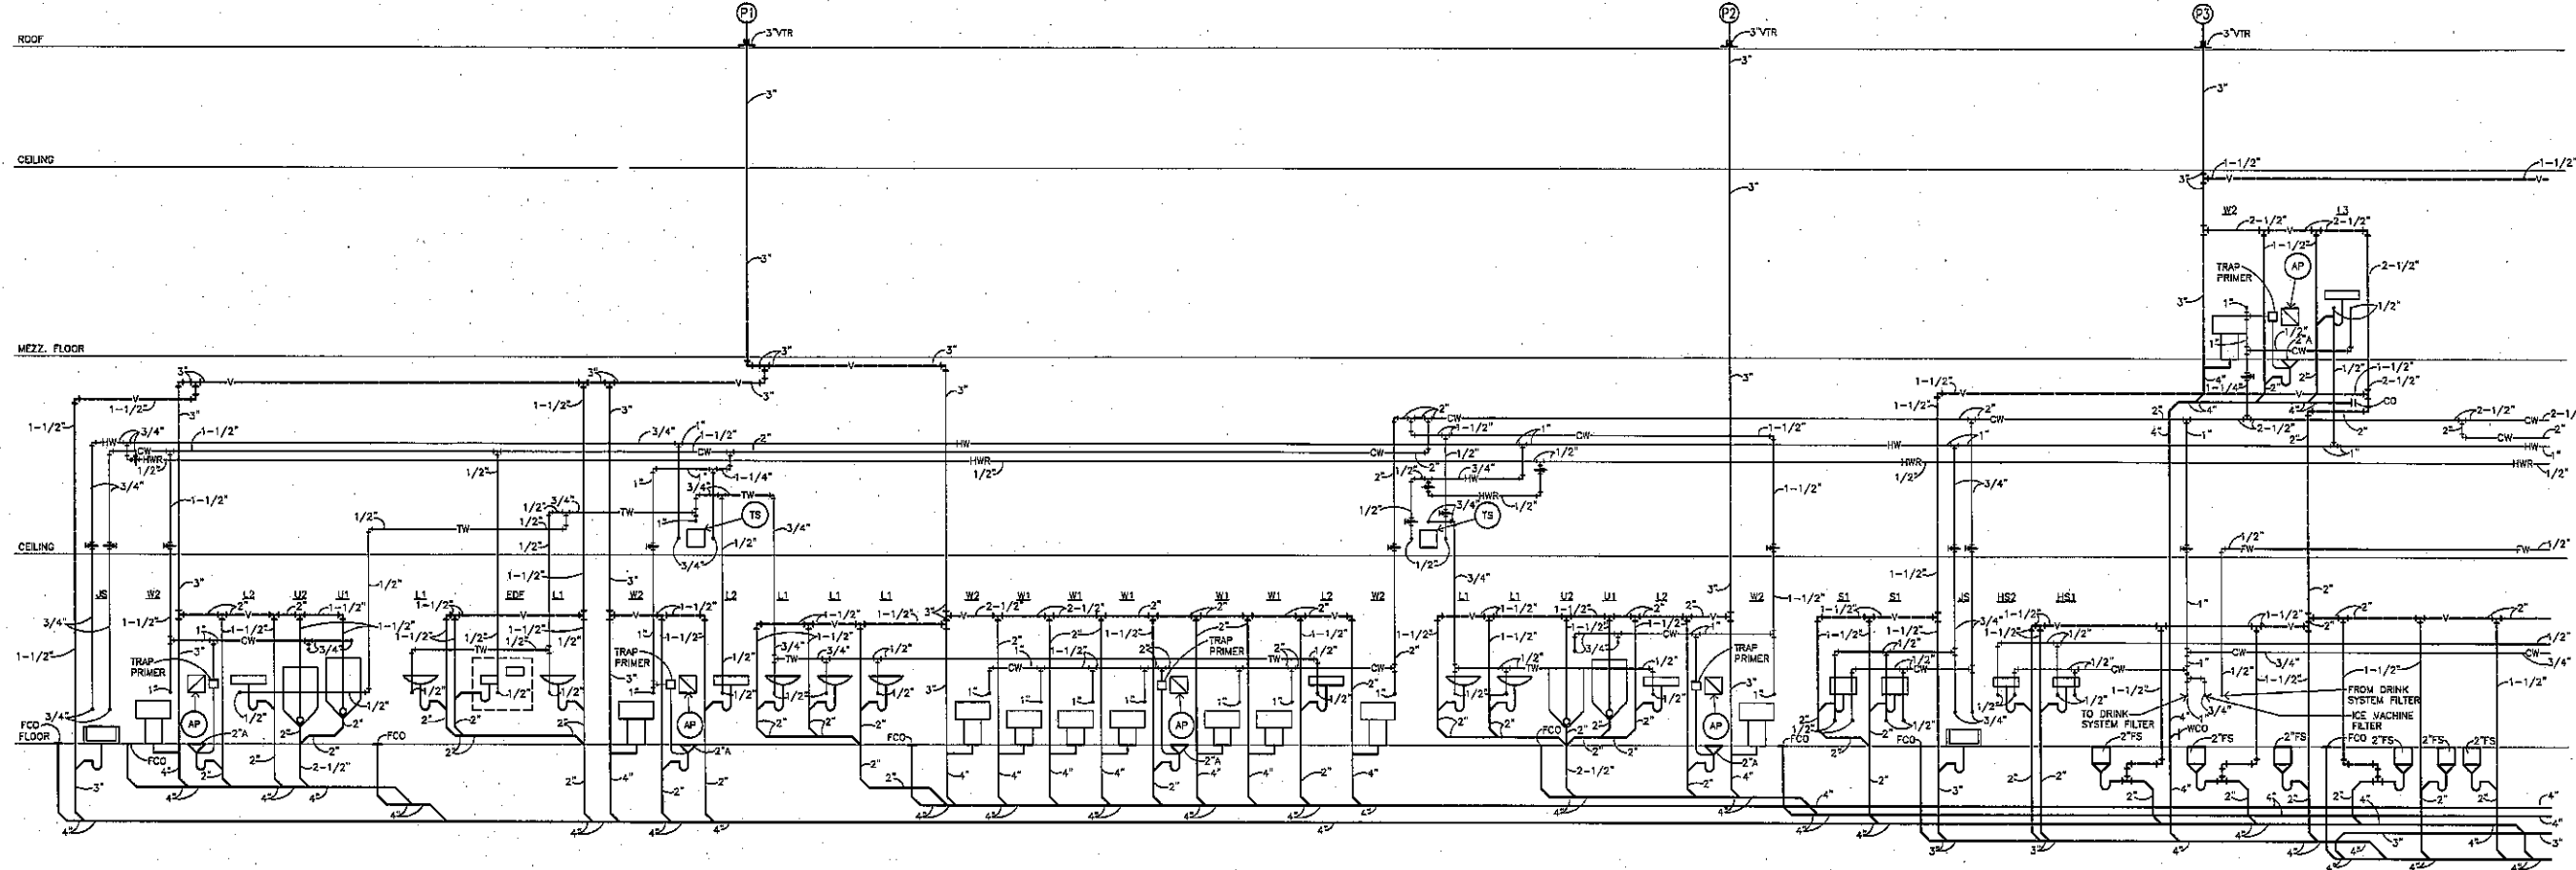

PLUMBING RISER DIAGRAM
NOT TO SCALE

Rolling Hills
St. Johns County, Florida

100 West 11th
St. Johns County, Florida 32057
Phone (904) 834-7522
Fax (904) 834-7522

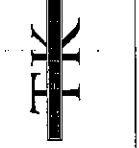

ROLLING HILLS
ST. JOHN'S COUNTY, FLORIDA



BID SET
06/18/07

REVISION LOG

NO.	DATE	FOR

JOB NO.: 06045.01
DWG. BY: JMD, CHK. BY: BFR.

PLUMBING
RISER
DIAGRAM

SHEET NO.

P4