

SYMBOLS - TELEPHONE SYSTEM (SEE DETAIL SHEET FOR CONFIGURATION)

SYMBOL	DESCRIPTION
TRB	TRB TELEPHONE OUTLET, MTD. 18" AFF. 0 INDICATES WALL MOUNTED
TRC	TRC TELEPHONE OUTLET, MTD. 48" AFF. 0 INDICATES WALL MOUNTED
TRD	TELEPHONE TERMINAL CABINET
TRF	EMPTY 3/4" TELEPHONE CONDUIT (UNLESS OTHERWISE NOTED)
TRG	TELEPHONE BACKBOARD (WALL MOUNTED)


SYMBOL	DESCRIPTION
TRM	OUTLET FOR TV MONITOR (CCTV SYSTEM)
TRN	TV CONDUIT RUN, MINIMUM 3/4" CONDUIT
TRP	CCTV CONDUIT RUN, MINIMUM 1" CONDUIT
TRQ	TEACHER MULTIMEDIA OUTLET (SEE DETAIL SHEET FOR CONFIGURATION)
TRR	STANDARD CATV OUTLET, SEE DETAIL SHEET FOR CONFIGURATION
TRS	TV + STANDARD TV OUTLET (SEE DETAIL SHEET FOR CONFIGURATION)
TRT	TV + TELEVISION MULTIMEDIA OUTLET (SEE DETAIL SHEET FOR CONFIGURATION)

SYMBOLS - COMPUTER SYSTEM (SEE DETAIL SHEET FOR CONFIGURATION)


SYMBOL	DESCRIPTION
TRU	NEW COMPUTER OUTLET, DOUBLE - MTD. 18" AFF. UNLESS OTHERWISE NOTED
TRV	EXIST. COMPUTER OUTLET, DOUBLE - MTD. 18" AFF.
TRW	NEW COMPUTER OUTLET, DUPLEX - MTD. 18" AFF. UNLESS OTHERWISE NOTED
TRX	NEW COMPUTER OUTLET, QUAD - MTD. 18" AFF. UNLESS OTHERWISE NOTED
TRY	NEW COMPUTER OUTLET, SIX - MTD. 18" AFF. UNLESS OTHERWISE NOTED
TRZ	NEW COMPUTER DATA CABLES NUMBER WIRES AS JACKS
TRA	NEW COMPUTER FIBER CABLE PLASTIC CONDUIT, 1/2" STRAND

SYMBOL	DESCRIPTION
TRB	EXIST. INTERCOM SPEAKER - WALL MOUNTED
TRC	EXIST. INTERCOM SPEAKER - CEILING MOUNTED
TRD	EXIST. INTERCOM CALL BACK - WALL MOUNTED
TRE	NEW INTERCOM SPEAKER - CEILING MOUNTED
TRF	EXIST. PBX TELEPHONE OUTLET, MTD. 18" AFF.

INSTALLATION NOTES
 A. DATA CABLES AND FIBER OPTICS TO BE INSTALLED ON RACEWAY
 B. ALL TELEPHONE CABLES TO BE INSTALLED ON RACEWAY

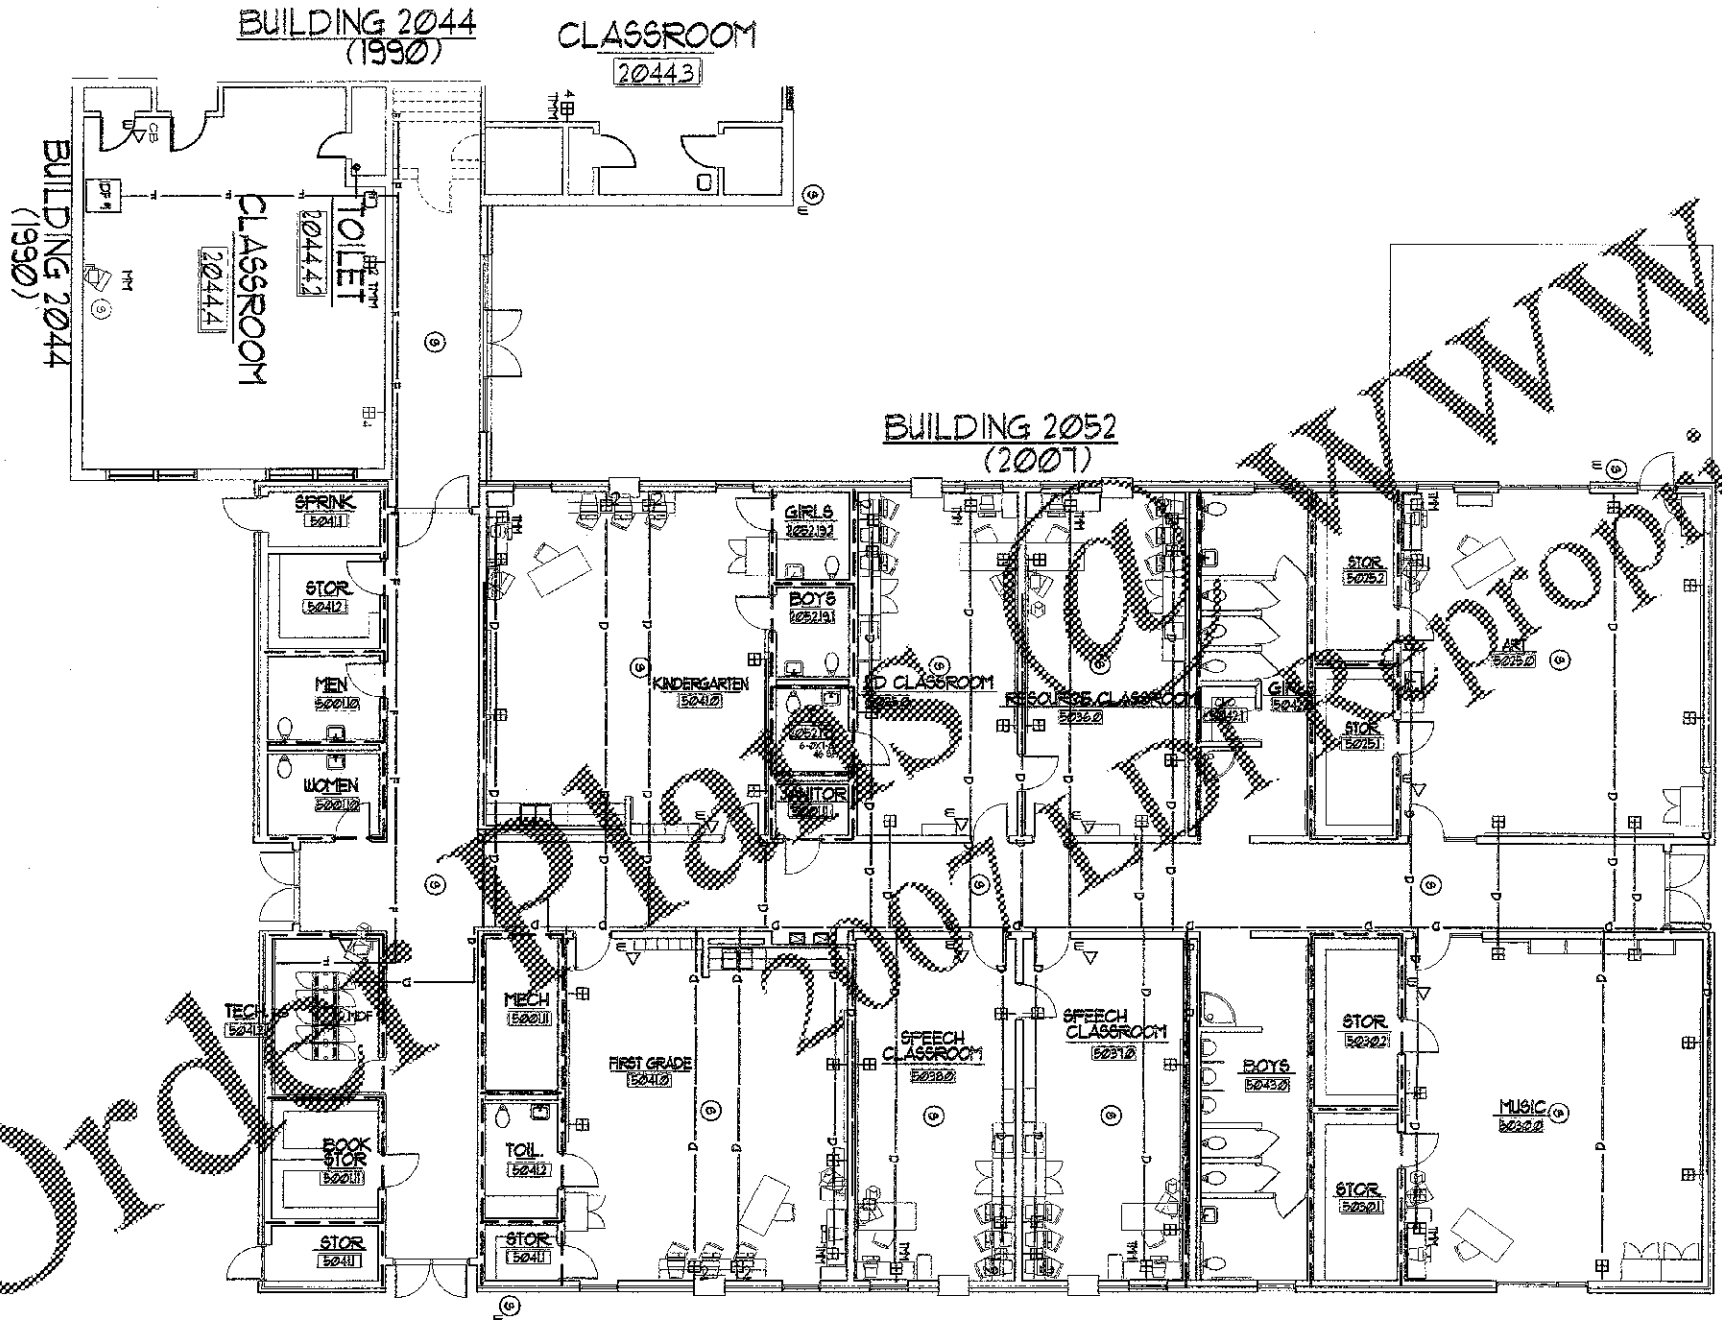

BUILDING 2052 TECHNOLOGY PLAN
 SCALE: 1/8" = 1'-0"

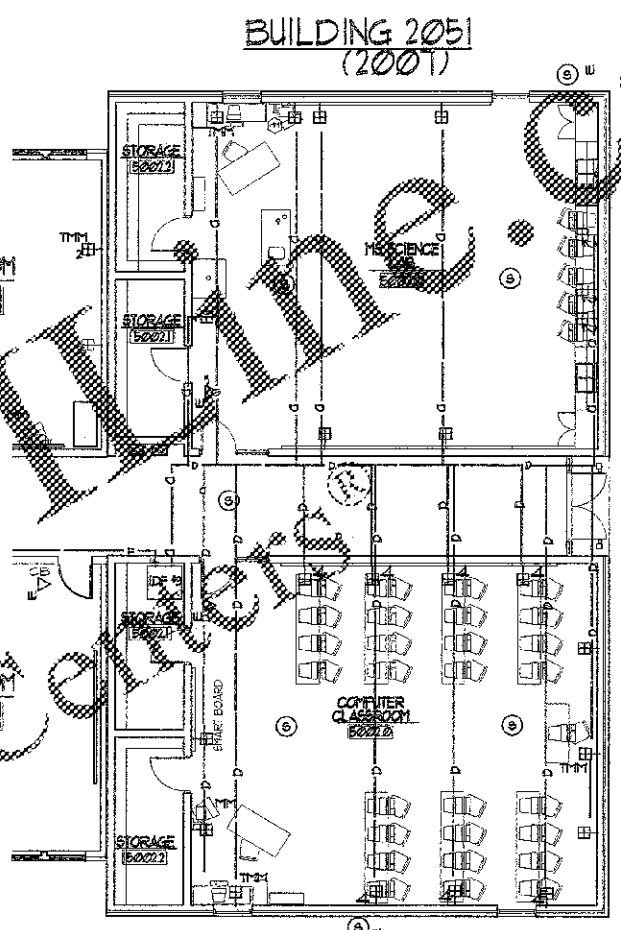


BUILDING 2051 TECHNOLOGY PLAN
 SCALE: 1/16" = 1'-0"


CHURCH STREET
 LYERLY, GEORGIA
 FTE COUNT 316
 1930'S GYM - 6,813 SQUARE FEET
 1966, 1969, 1976 - 8,848 SQUARE FEET
 1988 - 1,365 SQUARE FEET
 1990 - 2,468 SQUARE FEET
 1999 ADDITION - 20,252 SQUARE FEET
 2001 ADDITION 20510 - 3,255 SQUARE FEET
 2001 ADDITION 20520 - 9,656 SQUARE FEET
 TOTAL SQUARE FOOTAGE - 53,917 SQUARE FEET

LEGEND

A	BUILDING 2020
B	BUILDING 2040
C	BUILDING 2041
D	BUILDING 2042
E	BUILDING 2043
F	BUILDING 2044
G	BUILDING 2050
H	BUILDING 2051 (2001)
J	BUILDING 2052 (2001)

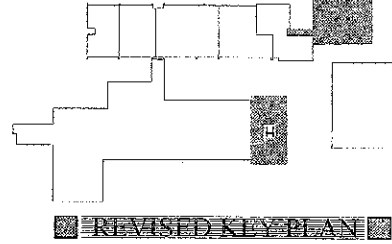


REVISED KEY PLAN

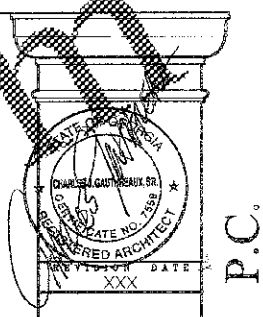

TECHNOLOGY UPGRADES TO
LYERLY ELEMENTARY SCHOOL
 CHATTOGA COUNTY BOARD OF EDUCATION
 LYERLY, GEORGIA

Member of
 The American Institute
 of Architects
 PROJECT NO.
 0702
 DATE
 JANUARY 2007

T-1.0
 OF
 63
 TOTAL

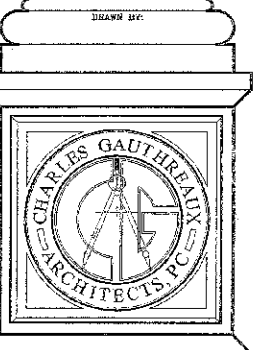

CHARLES GAUTHREAU ARCHITECTS, P.C.
 101 EAST SECOND AVENUE SUITE 300 • ROME, GEORGIA 30161-3137 • PHONE 706-236-9640 • FAX 706-236-9642

Order please

WWW.LDLINE.COM
 LDLINE.COM
 LDLINE.COM

SYMBOLS - TELEPHONE SYSTEM (SEE DETAIL SHEET FOR CONFIGURATION)

SYMBOL	DESCRIPTION
Ⓜ	PBX TELEPHONE OUTLET, MTD, 18" AFF. Ⓜ INDICATES WALL MOUNTED
Ⓜ	IS TELEPHONE OUTLET, MTD, 48" AFF. Ⓜ INDICATES WALL MOUNTED
Ⓜ	TELEPHONE TERMINAL CABINET
Ⓜ	EMPTTY 3/4" TELEPHONE CONDUIT UNLESS OTHERWISE NOTED
Ⓜ	TELEPHONE BACKBOARD (WALL MOUNTED)

SYMBOLS - COMPUTER SYSTEM (SEE DETAIL SHEET FOR CONFIGURATION)

SYMBOL	DESCRIPTION
Ⓜ	NEW COMPUTER OUTLET, DOUBLE - MTD, 18" AFF. UNLESS OTHERWISE NOTED
Ⓜ	EXIST. COMPUTER OUTLET, DOUBLE - MTD, 18" AFF.
Ⓜ	NEW COMPUTER OUTLET, DUPLEX - MTD, 18" AFF. UNLESS OTHERWISE NOTED
Ⓜ	NEW COMPUTER OUTLET, QUAD - MTD, 18" AFF. UNLESS OTHERWISE NOTED
Ⓜ	NEW COMPUTER OUTLET, SIX - MTD, 18" AFF. UNLESS OTHERWISE NOTED
Ⓜ	NEW COMPUTER DATA CABLES - NUMBER WIRES AS JACKS
Ⓜ	NEW COMPUTER FIBER CABLE PLASTIC CONDUIT, 1/2" STRAND

SYMBOLS


SYMBOL	DESCRIPTION
Ⓜ	OUTLET FOR TV MONITOR (CCTV SYSTEM)
Ⓜ	TV CONDUIT RUN, MINIMUM 3/4" CONDUIT
Ⓜ	CCTV CONDUIT RUN, MINIMUM 1" CONDUIT
Ⓜ	TEACHER MULTIMEDIA OUTLET (SEE DETAIL SHEET FOR CONFIGURATION)
Ⓜ	STANDARD CATV OUTLET, SEE DETAIL SHEET FOR CONFIGURATION
Ⓜ	TV - MULTIMEDIA TV OUTLET (SEE DETAIL SHEET FOR CONFIGURATION)
Ⓜ	TV - TELEVISION MULTIMEDIA OUTLET (SEE DETAIL SHEET FOR CONFIGURATION)

SYMBOLS

SYMBOL	DESCRIPTION
Ⓜ	RACEWAY
Ⓜ	4 CONDUIT RACEWAY
Ⓜ	EXISTING ISD OUTLET
Ⓜ	EXIST. INTERCOM SPEAKER - WALL MOUNTED
Ⓜ	EXIST. INTERCOM SPEAKER - CEILING MOUNTED
Ⓜ	EXIST. INTERCOM CALL BACK - WALL MOUNTED
Ⓜ	NEW INTERCOM SPEAKER - CEILING MOUNTED
Ⓜ	EXIST. PBX TELEPHONE OUTLET, MTD, 18" AFF.

INSTALLATION NOTES


1. REFER TO ALL OTHER SHEETS FOR CONDUIT AND RACEWAY SCHEDULES AND SIZES. REFER TO ALL OTHER SHEETS FOR CONDUIT SCHEDULES AND SIZES.

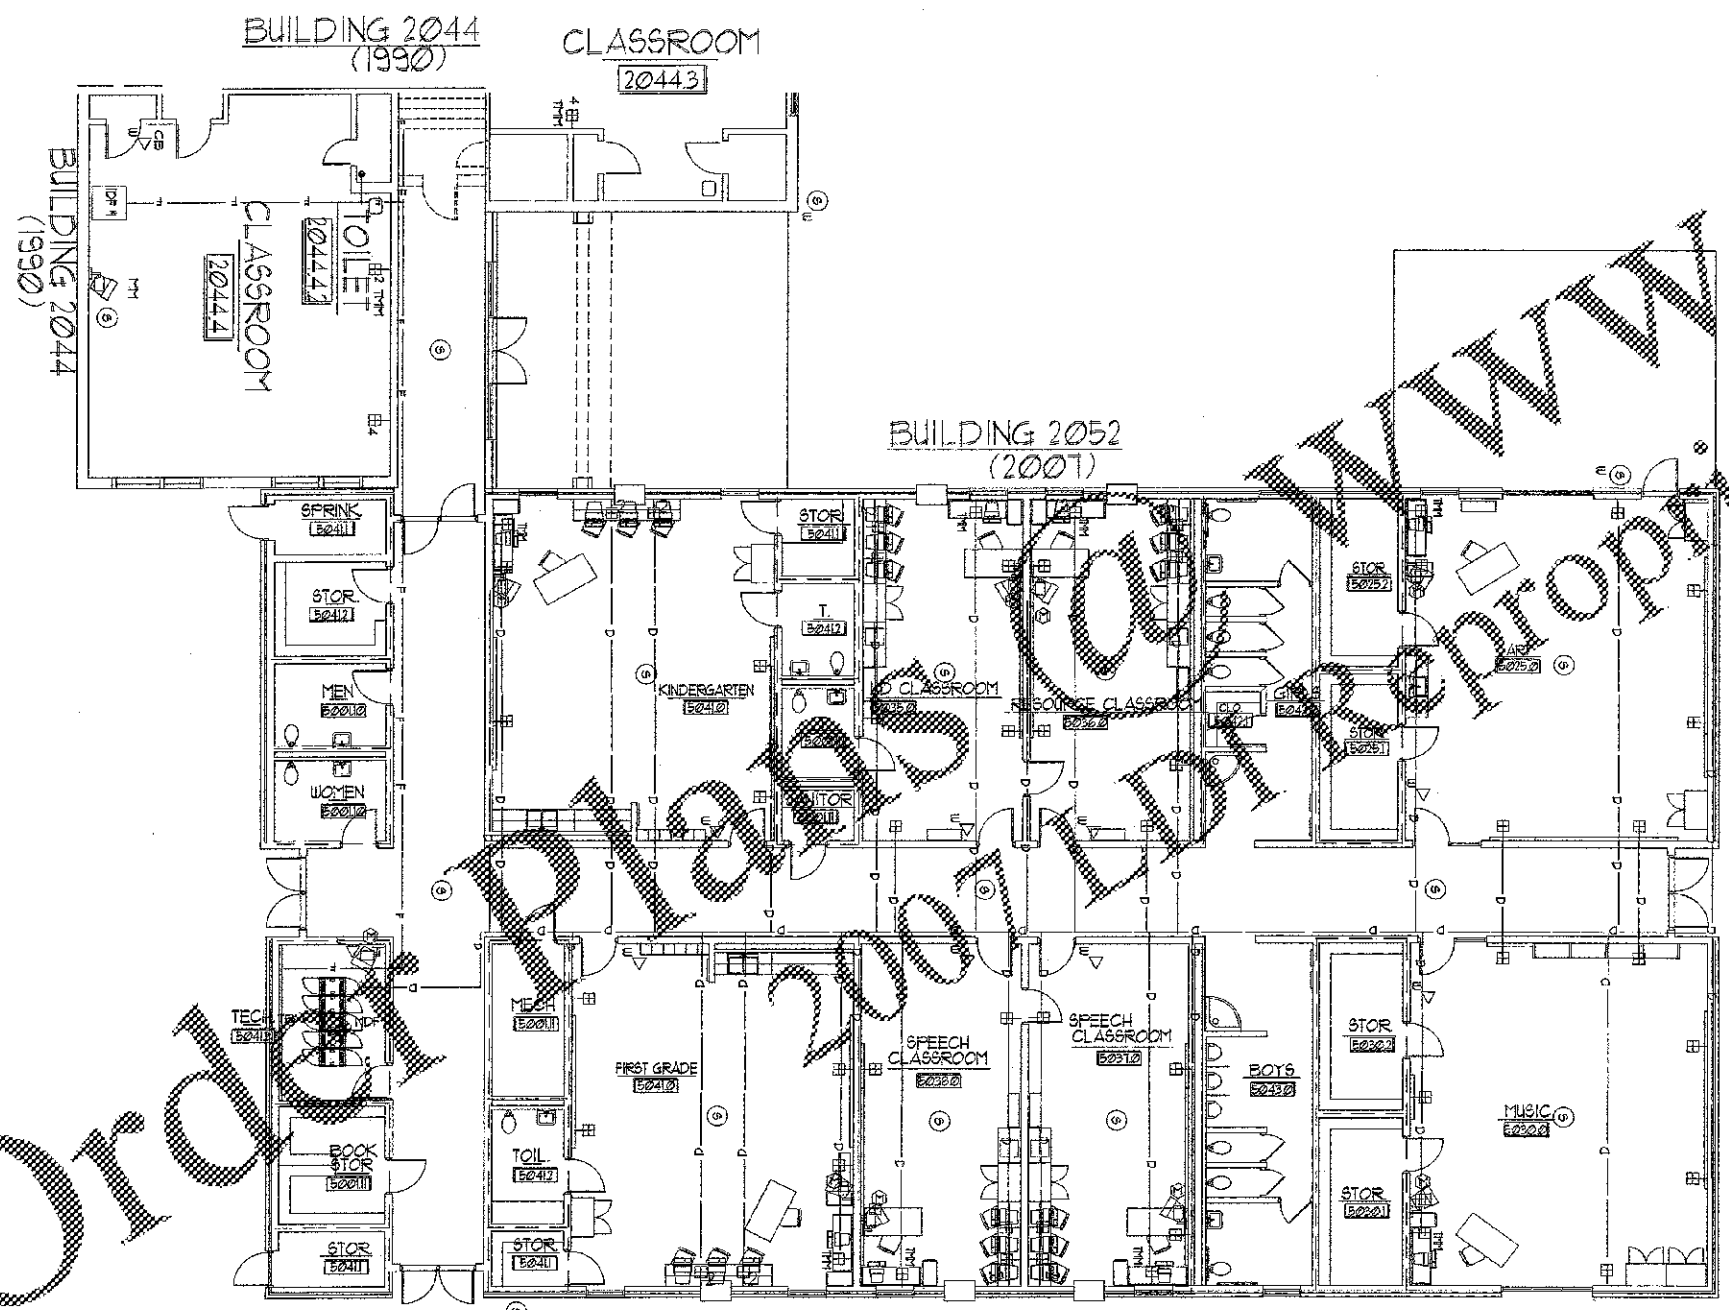

BUILDING 2052 TECHNOLOGY PLAN

SCALE: 1/8" = 1'-0"

CHURCH STREET
LYERLY, GEORGIA
FTE COUNT 383
18376 GYM - 6,813 SQUARE FEET
186618031816 - 8,218 SQUARE FEET
1998 - 1,969 SQUARE FEET
1998 - 2,488 SQUARE FEET
1998 ADDITION - 20,887 SQUARE FEET
2001 ADDITIONS - 1,311 SQUARE FEET
TOTAL SQUARE FOOTAGE - 83,311

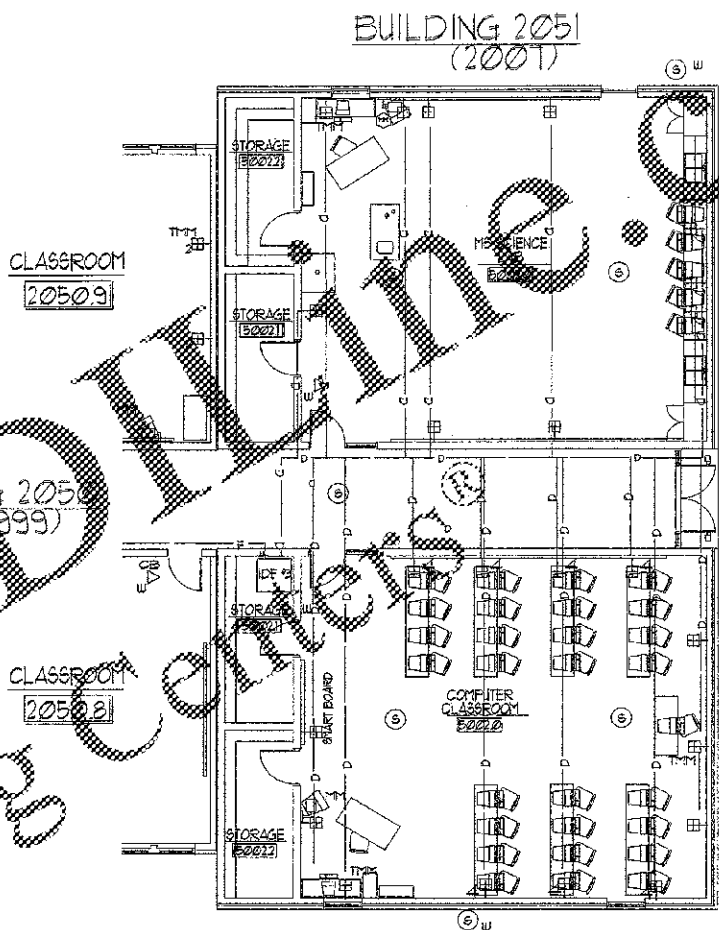


BUILDING 2051 TECHNOLOGY PLAN


SCALE: 1/8" = 1'-0"

LEGEND

A	BUILDING 2020
B	BUILDING 2040
C	BUILDING 2041
D	BUILDING 2042
E	BUILDING 2043
F	BUILDING 2044
G	BUILDING 2050
H	BUILDING 2051 (2007)
J	BUILDING 2052 (2007)

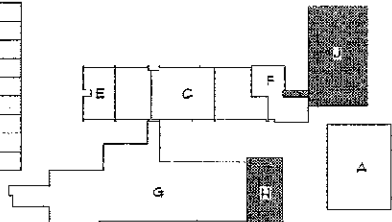

REVISED KEY PLAN

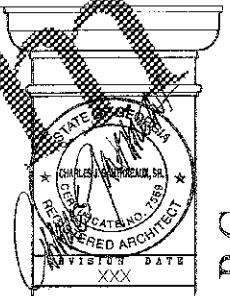


RENOVATIONS TO
LYERLY ELEMENTARY SCHOOL
CHATTOOGA COUNTY BOARD OF EDUCATION
LYERLY, GEORGIA




PROJ. NO. 0701
DATE JANUARY 2007

T-1.1
OF 63
TOTAL

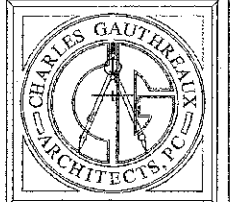


© CHARLES GAUTREAU ARCHITECTS PC

CHARLES GAUTREAU ARCHITECTS, P.C.
101 EAST SECOND AVENUE SUITE 300 • ROME, GEORGIA 30161-3137 • PHONE 706-236-9640 • FAX 706-236-9642

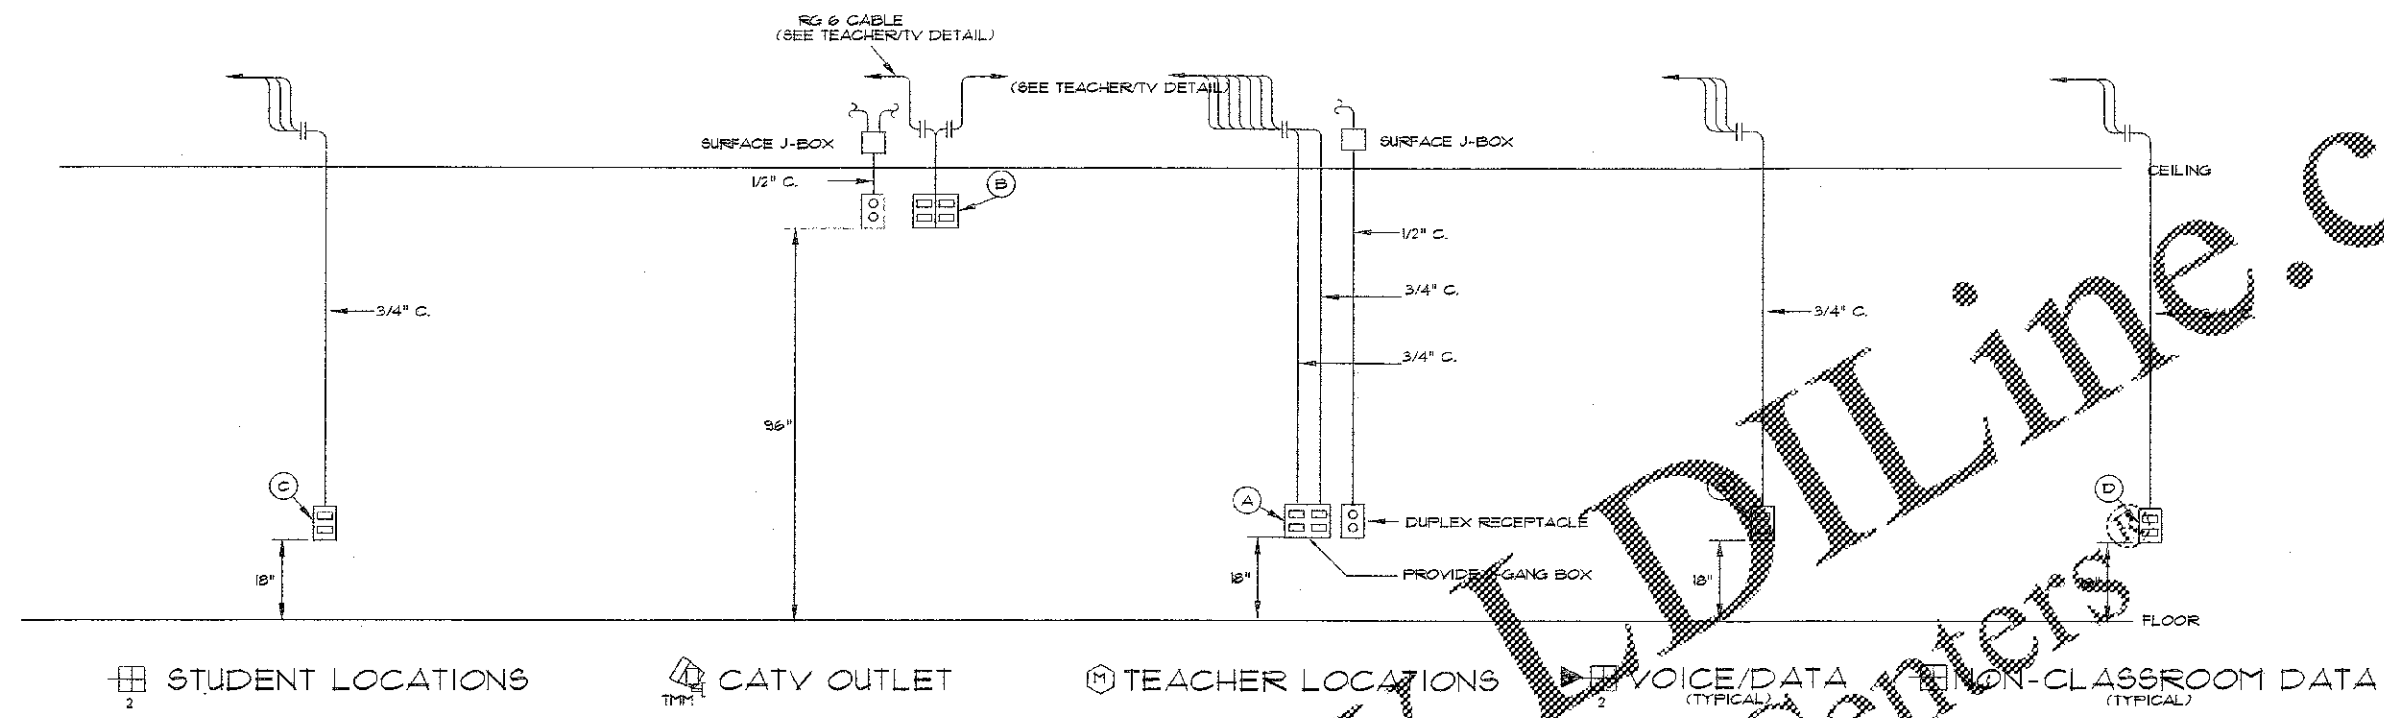


⊞ STUDENT LOCATIONS
 ⊞ CATV OUTLET
 ⊞ TEACHER LOCATIONS
 ⊞ VOICE/DATA (TYPICAL)
 ⊞ NON-CLASSROOM DATA (TYPICAL)


DATA-CATV OUTLET ELEVATIONS

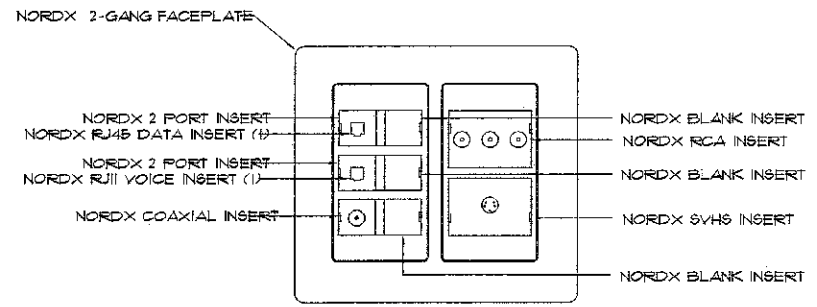


FACEPLATE "A" TEACHER MULTIMEDIA LOCATION

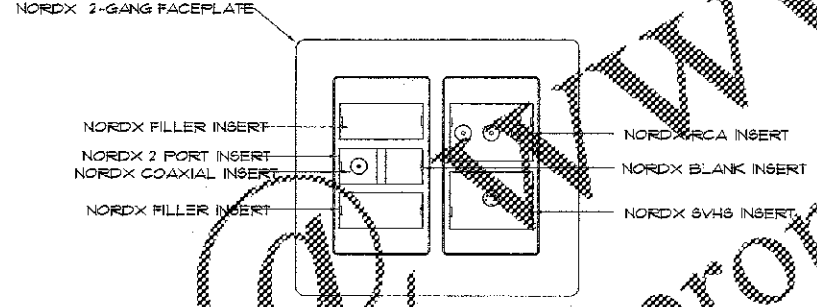


FACEPLATE "B" CLASSROOM MULTIMEDIA TV DROP

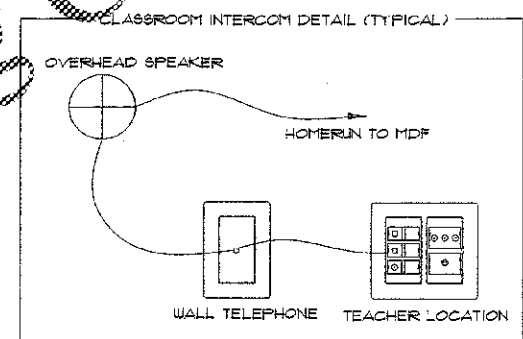


CLASSROOM INTERCOM DETAIL (TYPICAL)

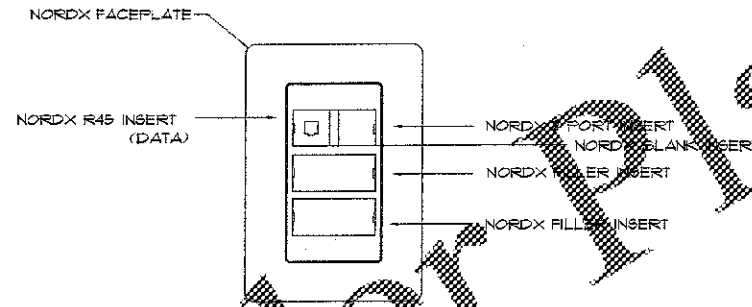


FACEPLATE "C" SINGLE DATA LOCATION

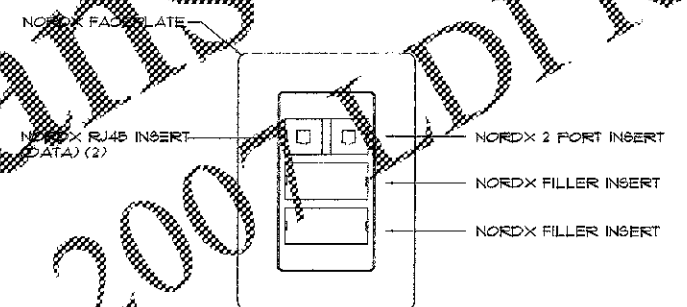


FACEPLATE "D" DUAL LOCATION

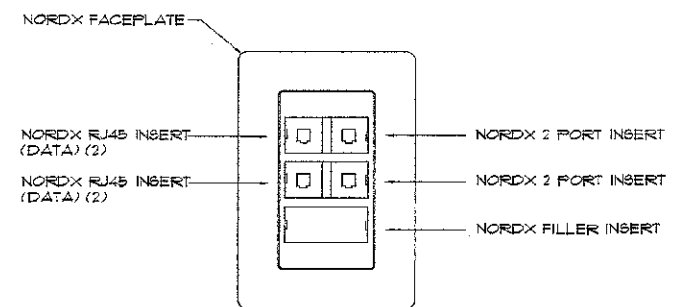


FACEPLATE "E" QUAD DATA LOCATION

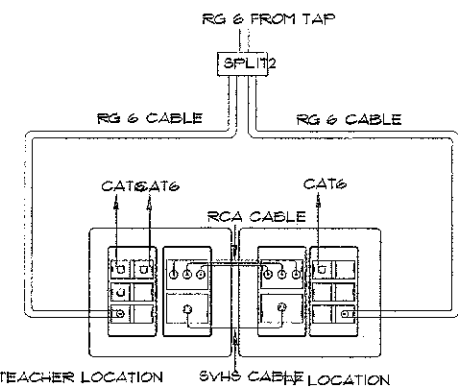


TEACHER/TV DETAIL

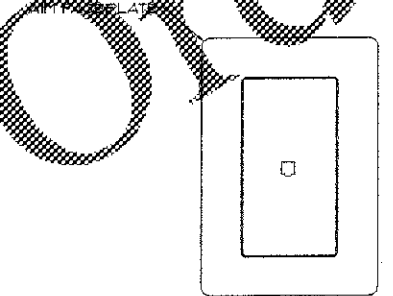

FACEPLATE "F" WALL PHONE LOCATION

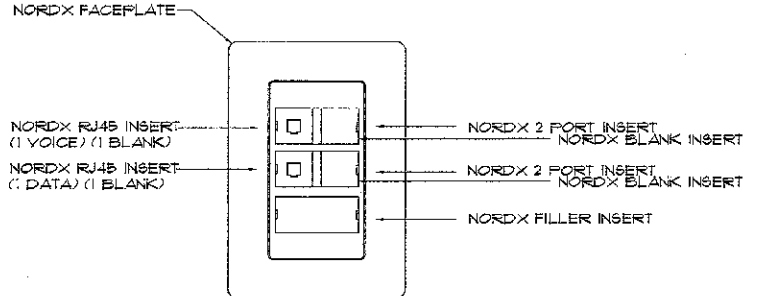

FACEPLATE "G" VOICE/DATA LOCATION

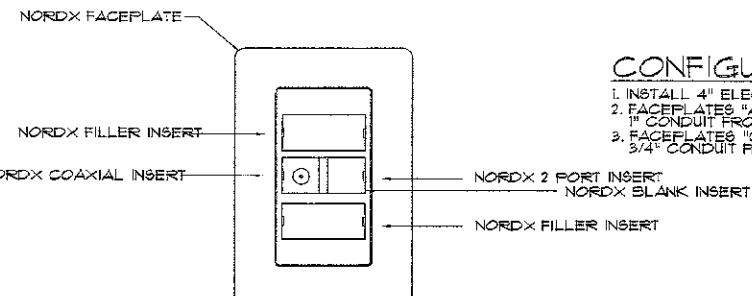

FACEPLATE "H" STANDARD TV OUTLET

CONFIGURATION NOTES

1. INSTALL 4" ELECTRICAL BOX AT ALL TECHNOLOGY OUTLET LOCATIONS
2. FACEPLATES "A", "B" AND "E" INSTALL 2 GANG PLASTER RING ON OUTLET BOX
3. FACEPLATES "C", "D", "F" AND "G" INSTALL 1 GANG PLASTER RING ON OUTLET BOX
- 3/4" CONDUIT FROM BOX TO ABOVE CEILING

Order Plans 2007

WWW.LDILine.com
 LD I Reproprinting Centers

TECHNOLOGY RENOVATIONS
LYERLY ELEMENTARY SCHOOL
 CHATTOGA COUNTY BOARD OF EDUCATION
 SUMMERVILLE, GEORGIA

PROJECT NO. 0701
 DATE JANUARY 2007
T-2.0
 OF 63
 TOTAL

CHARLES GAUTHREUX ARCHITECTS, P.C.

101 EAST SECOND AVENUE SUITE 300 • ROME, GEORGIA 30161-3137 • PHONE 706-236-9640 • FAX 706-236-9642